

40

35

30

25

20

ELEVATION



1 HAUGHTON BUILDING - ELEVATION 4A  
SCALE: 1:100  
METERS



LEGEND  
Architectural details

- Finished Floor level
- Spot height
- Window sill and head heights
- Stairs
- Structural Columns
- Interior Walls
- Partition Type (see schedule)
- Plumbing fixtures, toilets, sinks
- Cut line
- Door (with head height)
- Sliding door
- Window
- Glazing Type (see schedule)
- Door Type (see schedule)
- Railing
- Fencing

Murphy Surveys Ltd. Disclaimer

The user or recipient of this survey data understands and acknowledges this data may be inaccurate or contain errors or omissions and the user or recipient assumes full responsibility for any risks or damages resulting from, arising from, or in connection with any use of or reliance upon data displayed herein. Although significant care has been exercised to produce surveys that satisfy survey accuracy standards, these surveys are only as accurate as the source data from which they were compiled. Although all reasonable steps have been taken to locate all features visible at the time of the survey, there is no guarantee that all will be shown on the drawing, as some above ground features may have obstructed the survey. Wherever possible, areas unable to be surveyed will be labelled as "UTS".

The Company shall not be liable for any inaccuracy of the data provided beyond the specified scale or accuracy, or for any matters resulting from their use for purposes other than that stated in the Contract. No liability shall attach to the Surveyor in respect of any consequential loss or damages suffered by the Client. The Client must promptly notify the Company of any errors in mapping of which it becomes aware. If misleading, inaccurate or otherwise inappropriate information is brought to the Company's attention or the Company itself identifies any such inaccuracy or error in a survey, it shall use its reasonable endeavours to fix or remove it and if necessary in certain instances, the Company being on notice of any such misleading, inaccurate or otherwise inappropriate information, it will re-conduct the survey and reproduce the data to within the specified scale or accuracy.

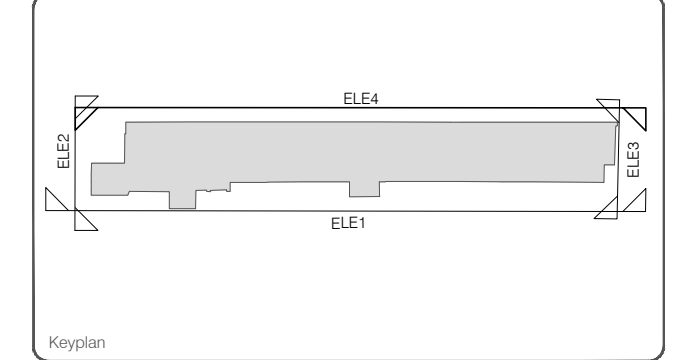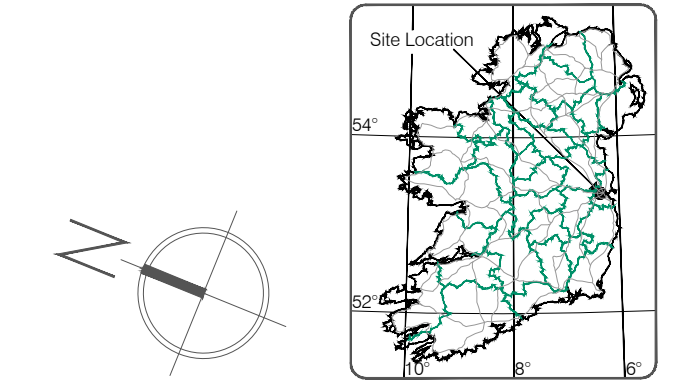

Surveyed by	Murphy Surveys Ltd.	Date	APRIL 2015	Drawn	Main Head
Drawn by	MSL	Date	MAY 2015	Grid System	
Checked by	MR	Date	26/05/2015	Irish National Grid	<input checked="" type="checkbox"/> ITM 62
Revisions					
No.	Date	Description			
0	13/05/2015	ISSUED FINAL DRAWINGS			
1	26/05/2015	DETAILS ADDED			

No. 318

THE SURVEY ASSOCIATION FULL MEMBER

**murphy** SURVEYS  
GLOBAL CONSULTING SURVEYORS

Topographic surveys, Measured Building Surveys, Setting Out, As-Built Surveys, Hydrographic Surveys, Legal Mapping, Pipeline Surveys, Services Location, Ground Penetrating Radar, Laser Scanning, Rectified Photography

Kildare Cork Belfast Glasgow London

**Head Office**  
Global House  
Kilcullen Business Campus  
Kilcullen Co. Kildare  
Ireland

Phone: (+353) 045 484040  
Fax: (+353) 045 484004  
Email: info@murphysurveys.ie

[www.murphysurveys.ie](http://www.murphysurveys.ie)

<b>Client :</b>		O'CONNOR SUTTON CRONIN	
<b>Project :</b>		NEW CHILDRENS HOSPITAL - EXTENDED SCOPE	
<b>Date :</b>	13/05/2015	<b>Scale :</b>	1:100
<b>Description :</b>		HAUGHTON BUILDING - ELEVATIONS	
<b>Drawing Number :</b>	NCH-G-MY-TS-XX-ST-1312		
© Copyright 2015 MURPHY SURVEYS LTD			

2 HAUGHTON BUILDING - ELEVATION 4B  
SCALE: 1:100  
METERS

